

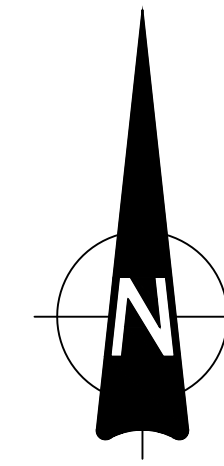


SITE PLAN – FOUL PUMPING STATION
SCALE 1:200

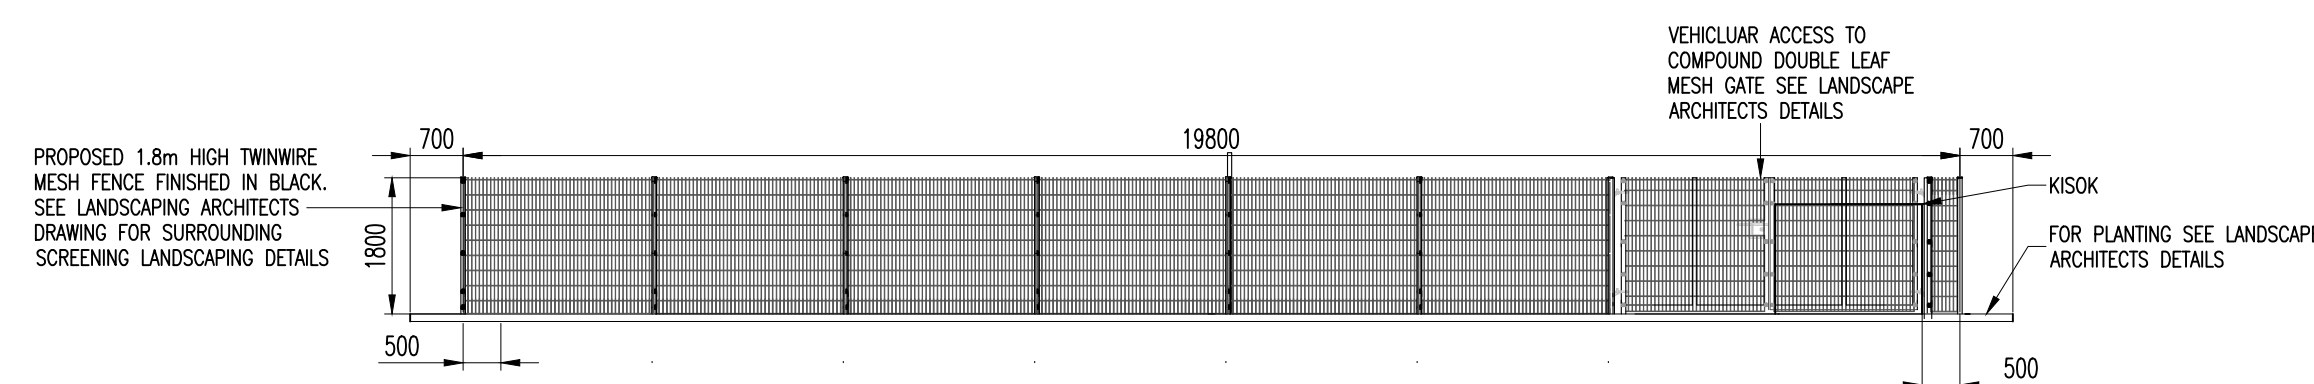


NOTES:


1. DO NOT SCALE. USE FIGURED DIMENSIONS ONLY.
2. THIS DRAWING IS TO BE READ IN CONJUNCTION WITH ALL OTHER RELEVANT ARCHITECTURAL AND ENGINEERING DRAWINGS.

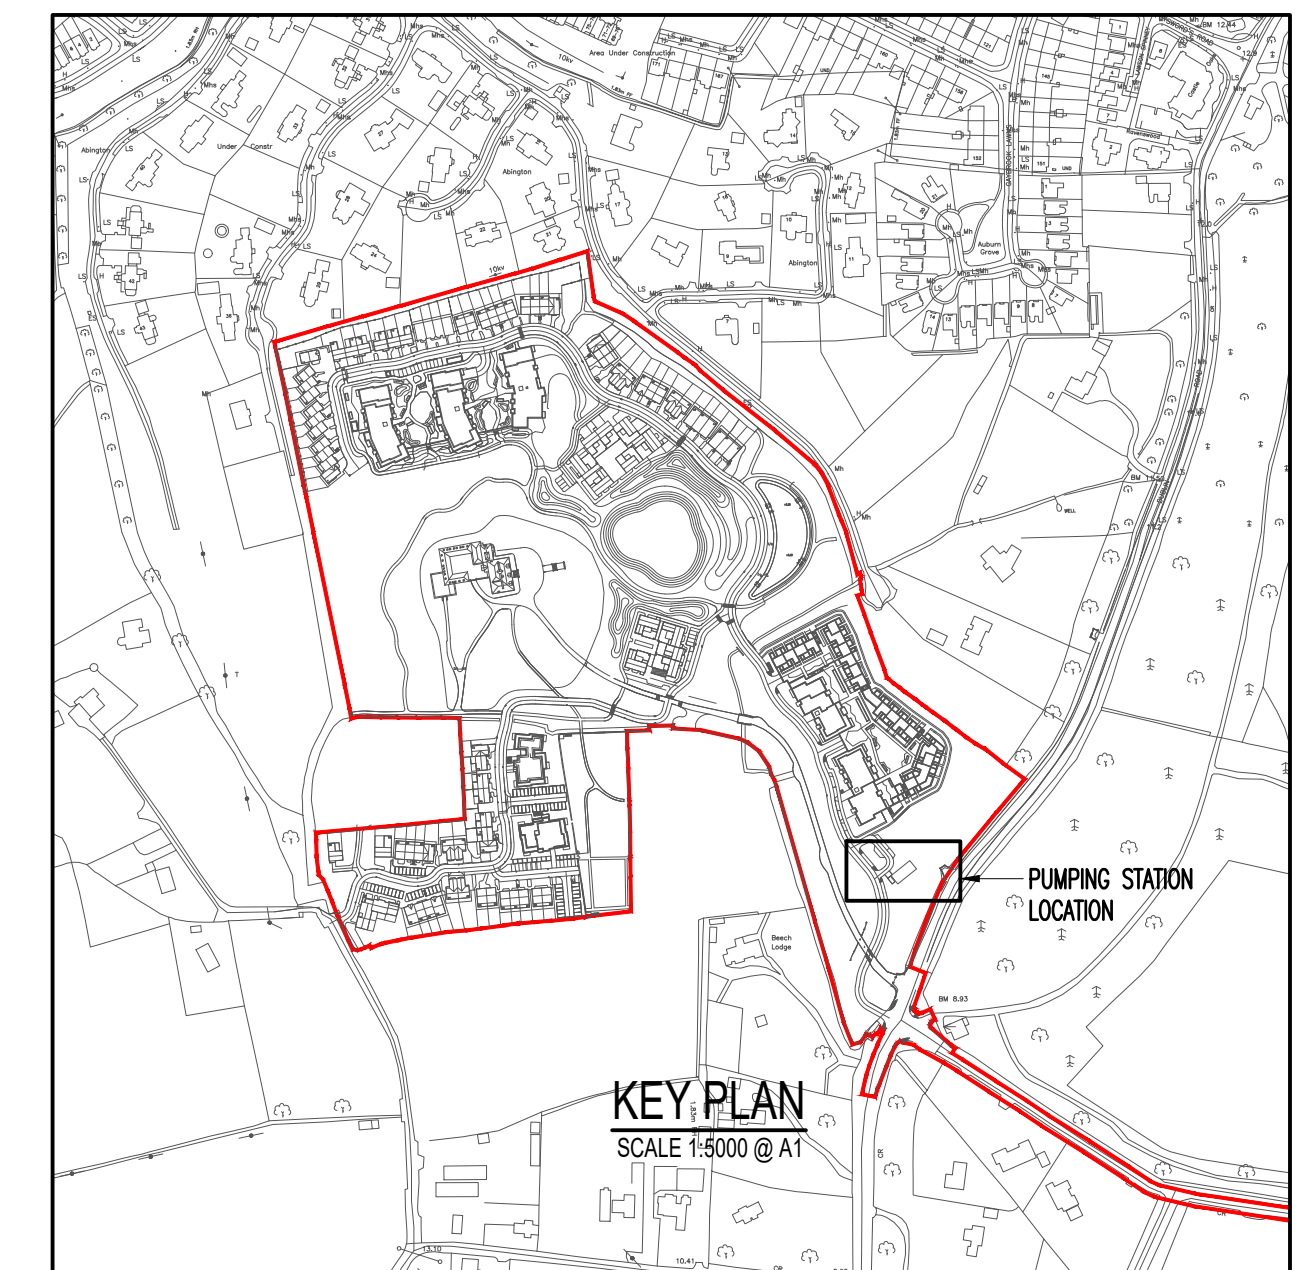


PROPOSED ELEVATION A-A
SCALE 1:100

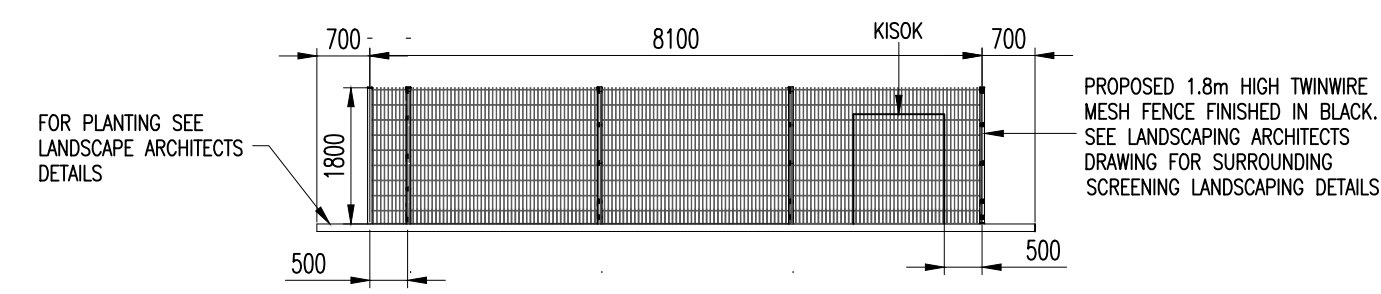


PROPOSED ELEVATION D-D
SCALE 1:100

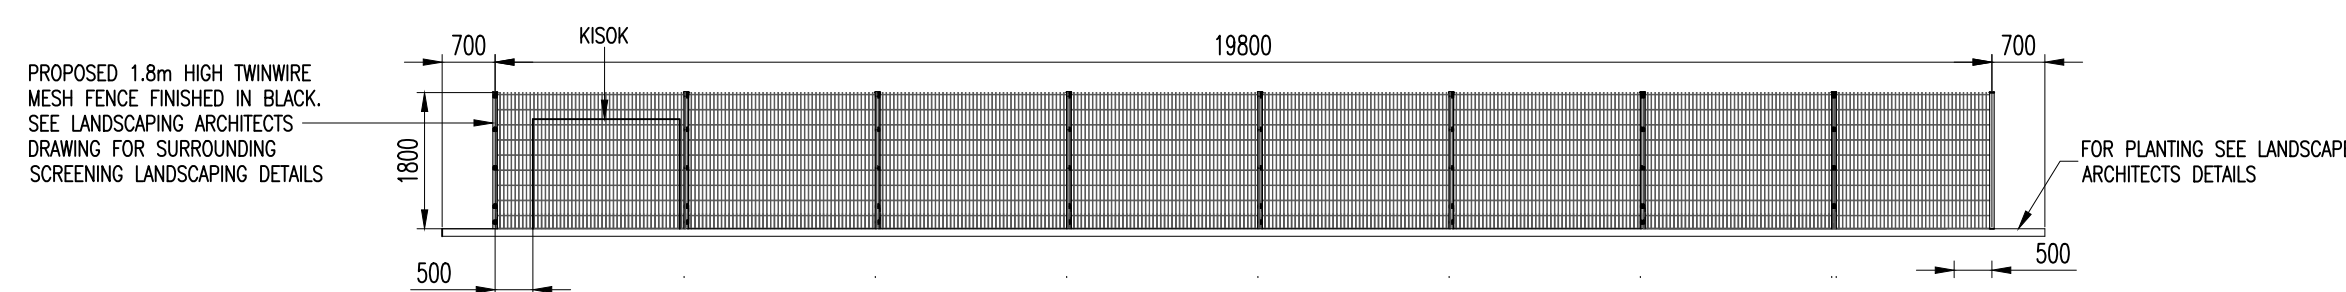

PROPOSED ELEVATION B-B
SCALE 1:100

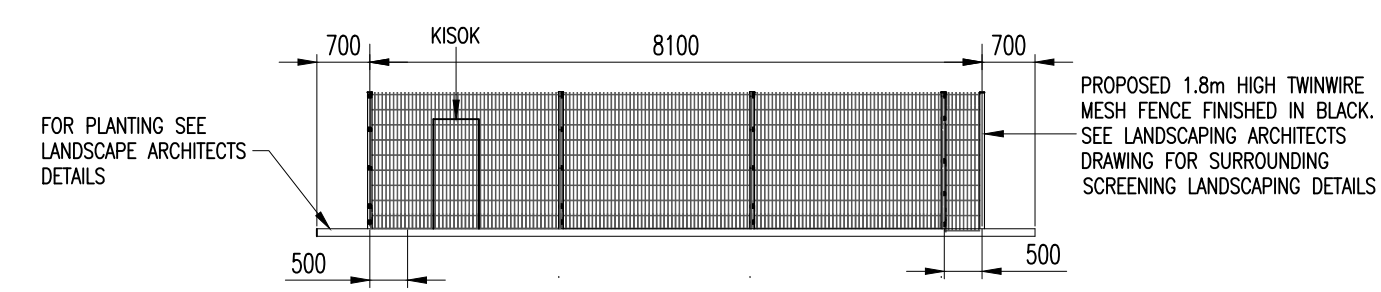

PROPOSED ELEVATION C-C
SCALE 1:100

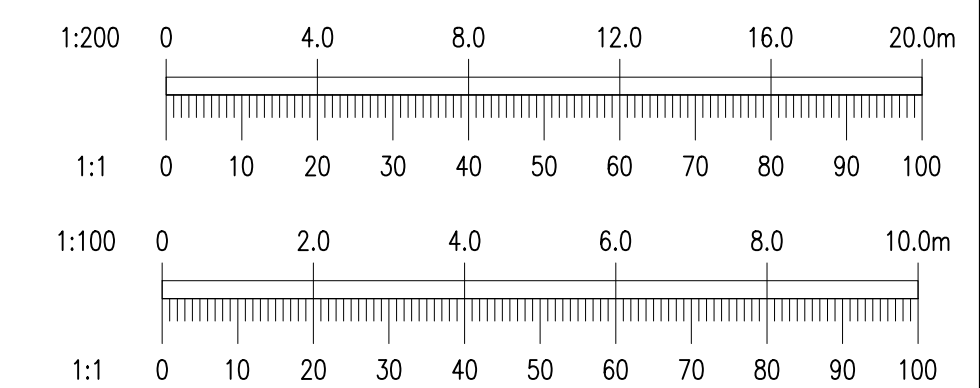

REV.	DATE	AMENDMENT	DRN	APPD

STATUS **PLANNING**

Waterman Moylan
Engineering Consultants

BLOCK 8, EASTPOINT BUSINESS PARK, ALFIE BYRNE ROAD,
DUBLIN D03 H3F4 IRELAND. Tel: (01) 664 8900
Email: info@waterman-moylan.ie www.waterman-moylan.ie

CLIENT **KINWEST LTD.**

ARCHITECT **CONROY CROWE KELLY ARCHITECTS**

PROJECT **AUBURN, MALAHIDE, CO. DUBLIN**

TITLE **FOUL WATER PUMPING STATION ELEVATIONS**

DRAWN PJD	DESIGNED MD	APPROVED MD	DATE APRIL 22'
SCALE AS SHOWN @ A1	JOB NO. 19-020	DRG. NO. P207	REVISION